


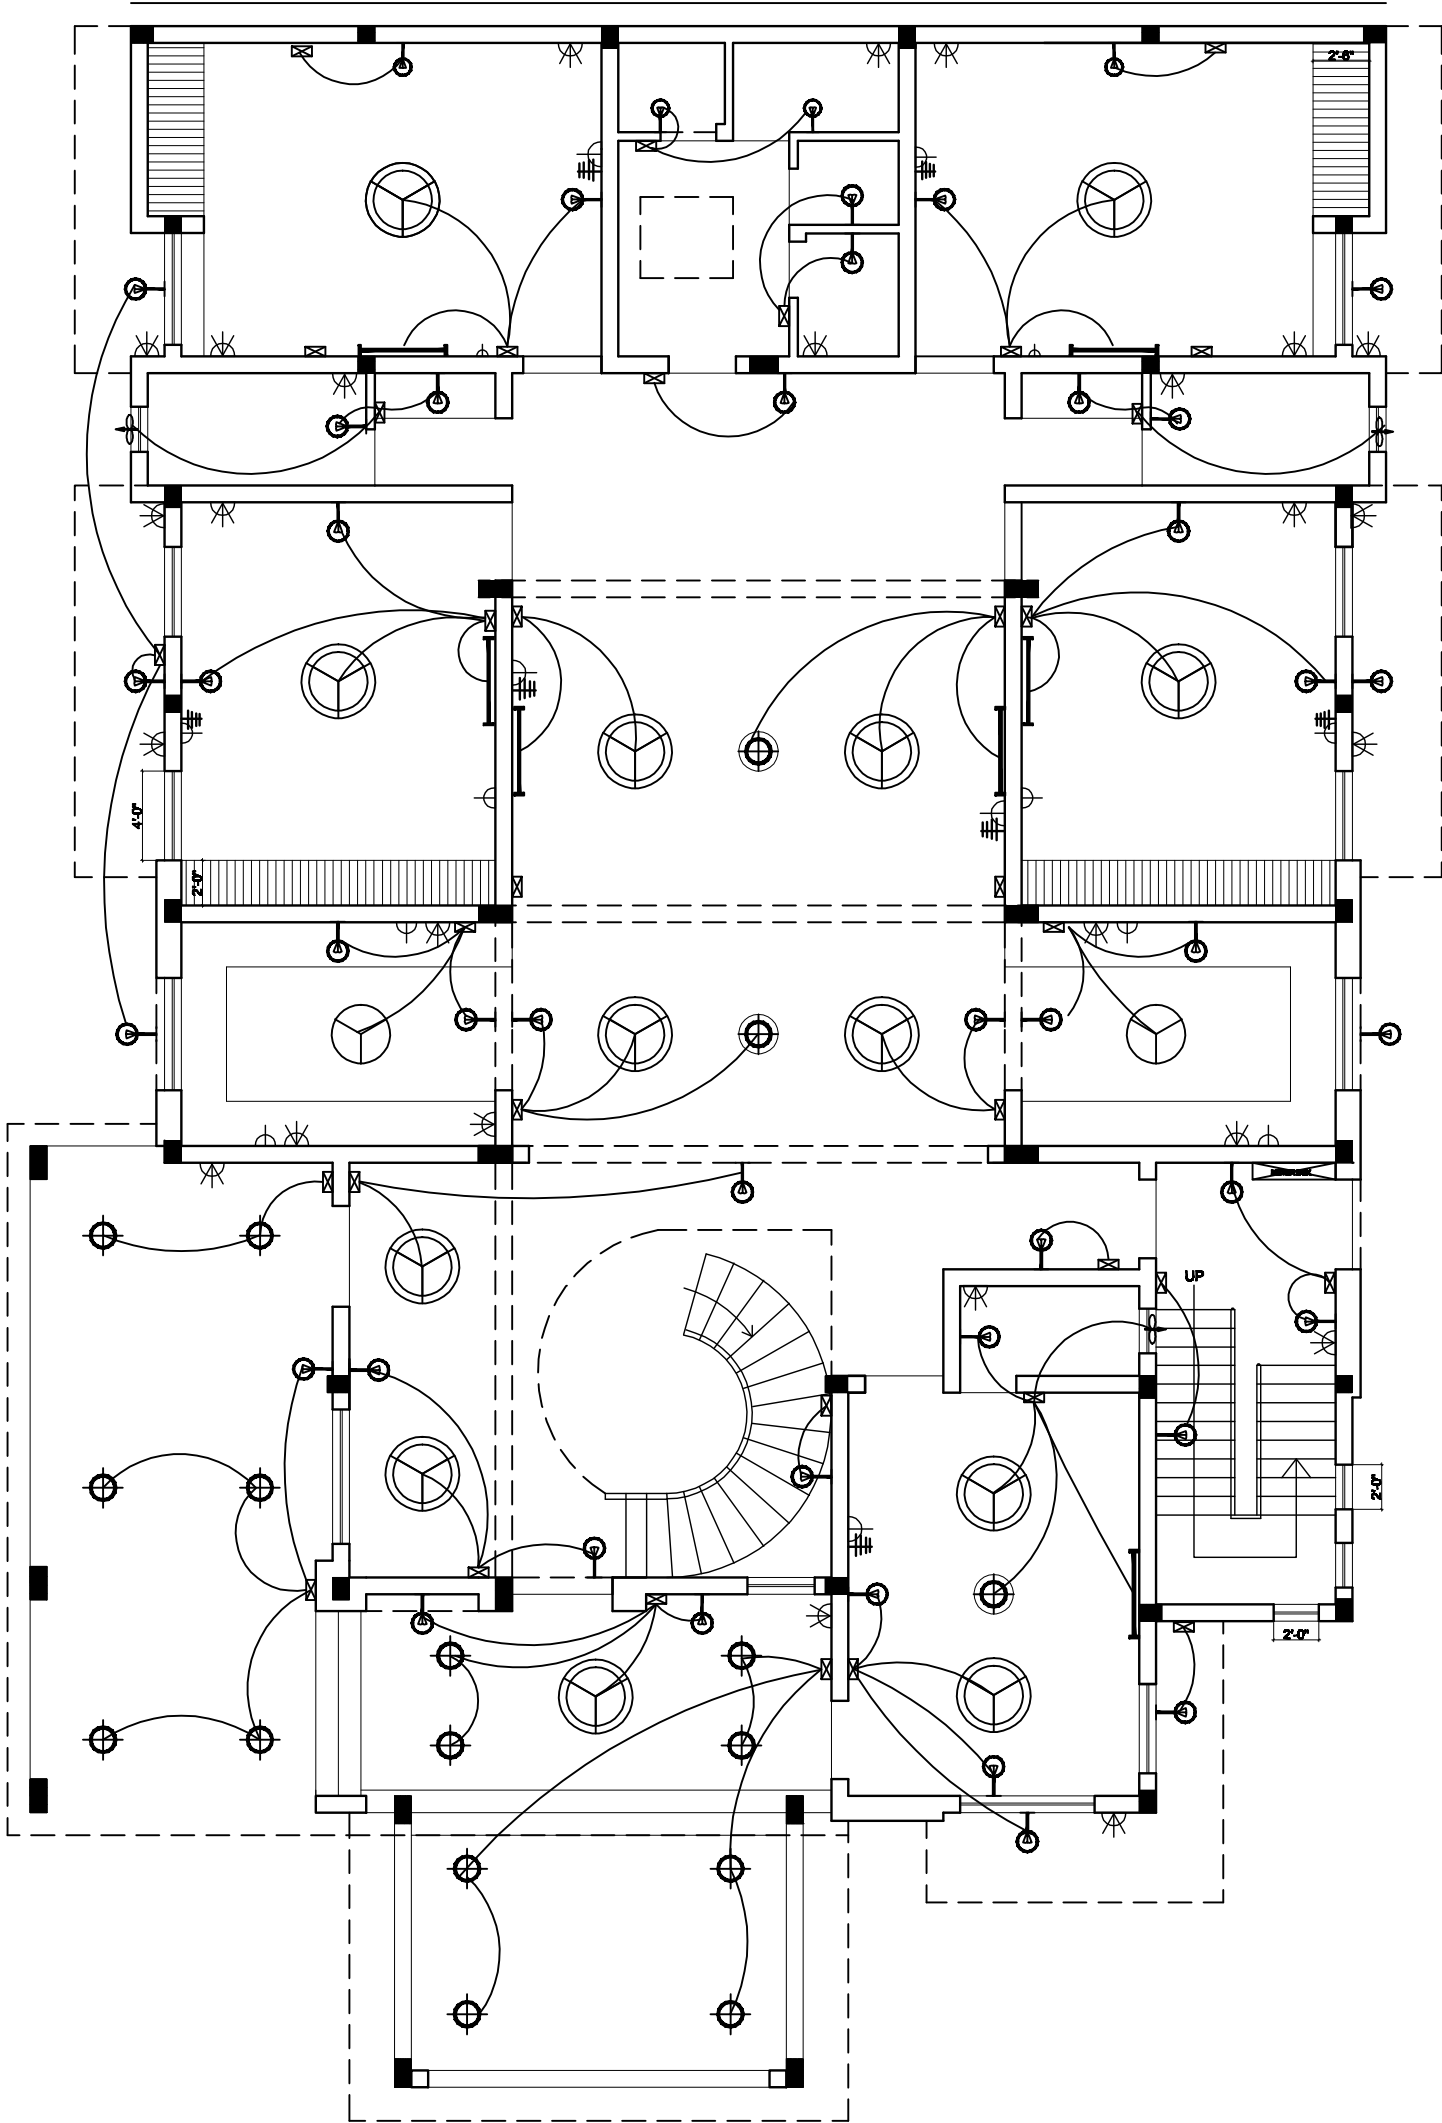

ELECTRICAL PLAN

PROJECT
PROPOSED RESIDENCE

COLUM CENTER
LAYOUT PLAN

OWNER

NOTE:-
SPECIAL NOTES:

DATE	DATE	DATE	DATE
DATE	DATE	DATE	DATE

TITLE
GROUND FLOOR PLAN

SCALE N.T.S.	DATE	DRAWN BY.
DRG. NO.	CHECKED BY.	

OWNER'S SIGN.

ARCHITECT'S SIGN.

MEHAR GRAPHICS
ARCHITECT
ENGINEER & INTERIOR DESIGNER
ADD:-
PASHUPATI VIHAR COLONY
NEAR PILLIBHIT BYPASS BAREILLY.
MB-09837786980,
E-MAIL : tarique210979@yahoo.com